



4 S Main Street, Suite 1300
Dayton, OH 45402
T 937.224.4474
thinkchamplin.com

THINK CREATE REALIZE



GDRTA 901
RESTROOM/
LOCKER ROOM

ISSUANCES

No.	Description	Date
3	ADDENDUM 2	06.08.21
2	FOR CONSTRUCTION	11.06.20
1	PRELIMINARY	10.08.20

Drawn By
Author
Checked By
Checker
Client Number
634
Project Number
6629




11-6-2020


DRAWING TITLE
HVAC PLAN - NEW WORK

SHEET NO.
M101

- NOTES**
- INSTALL NEW EXHAUST FAN ON ROOF ABOVE. ROUTE NEW DUCTWORK THROUGH EXISTING OPENING IN ROOF. FIELD VERIFY EQUIPMENT CONNECTION SIZES AND TRANSITION AS REQUIRED. PROVIDE ROOF CURB ADAPTER TO MATCH EXISTING OPENING SIZE. EQUIPMENT EXPOSED TO WIND SHALL HAVE POSITIVE ATTACHMENT TO THE BUILDING STRUCTURE TO COMPLY WITH WIND LOAD REQUIREMENTS OF THE BUILDING AND MECHANICAL CODES. REFER TO SPECIFICATION SECTION 23 05 30 FOR REQUIREMENTS.
 - WIRING BETWEEN THE MOST AT AND UNIT HEATER SHALL BE BY H.C.
 - INTERLOCK FAN WITH OCCUPANCY SENSORS PROVIDED BY E.C. FAN SHALL BE ENABLED WHEN OCCUPANCY SENSOR IN EITHER LOCKER ROOM IS ACTIVATED. WIRING BETWEEN OCCUPANCY SENSORS AND FAN SHALL BE BY H.C.

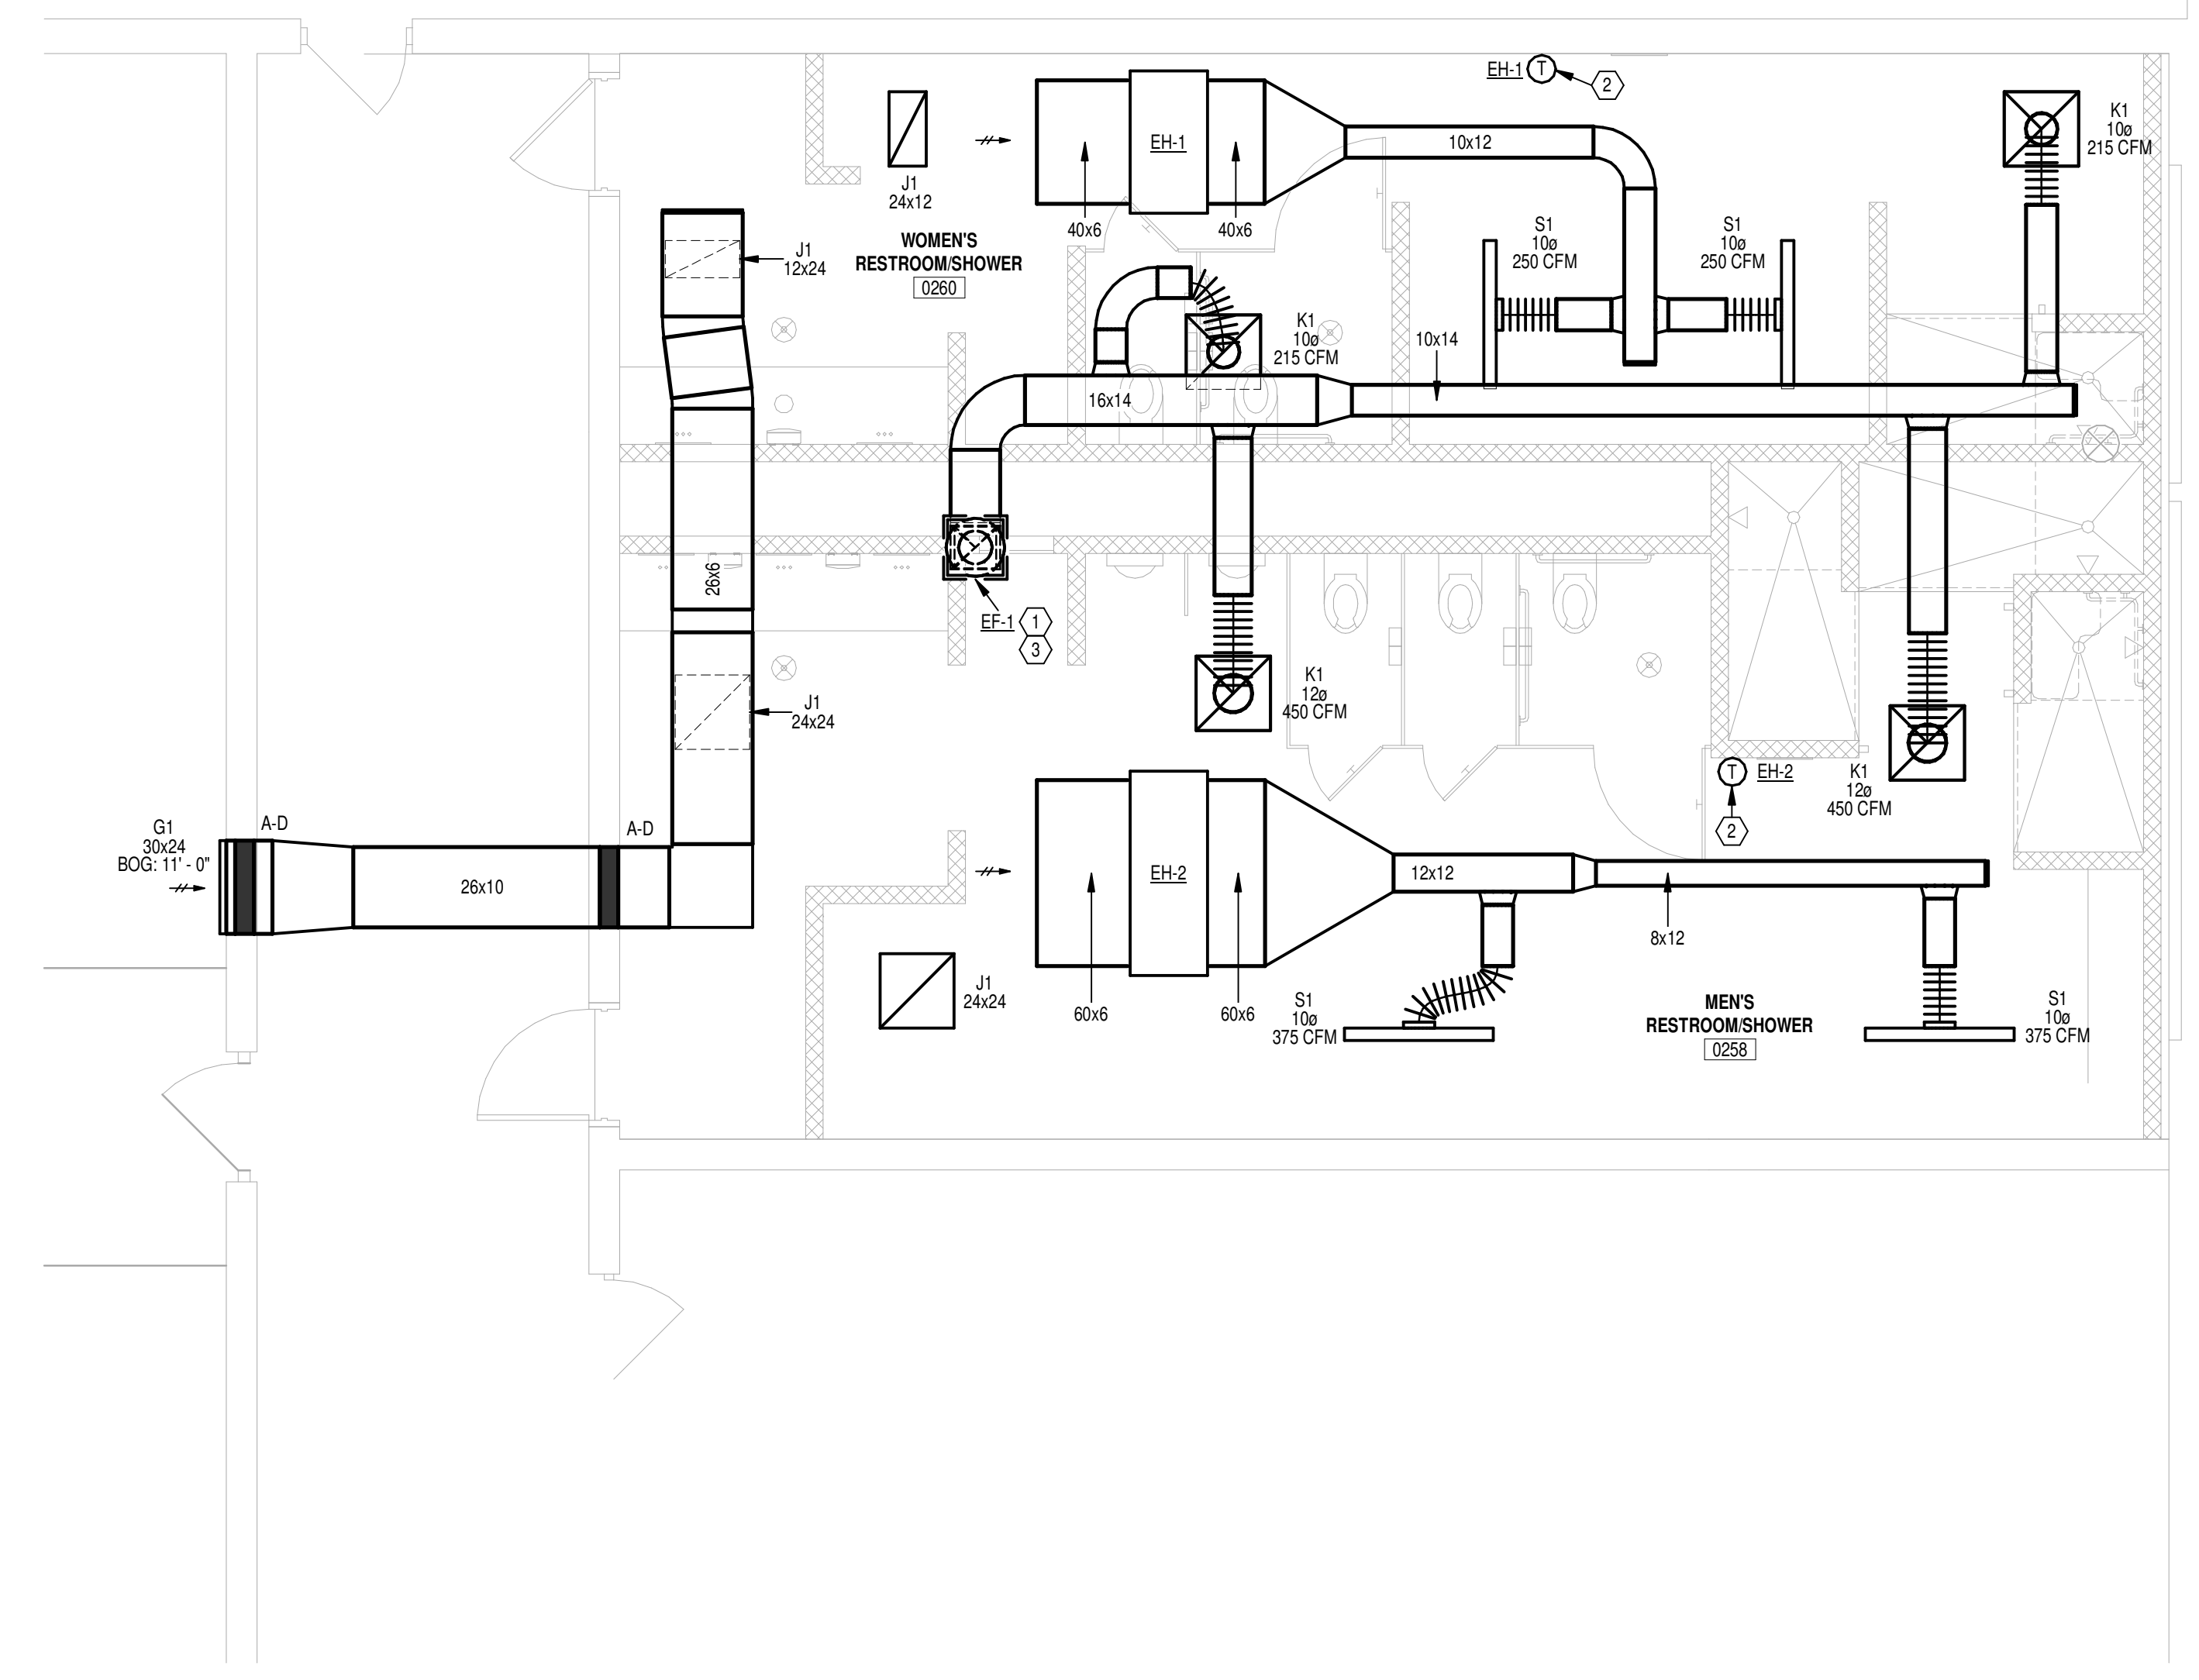

1 - HVAC - NEW
SCALE: 1/4" = 1'-0"

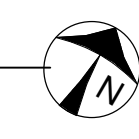

FOR CONSTRUCTION